

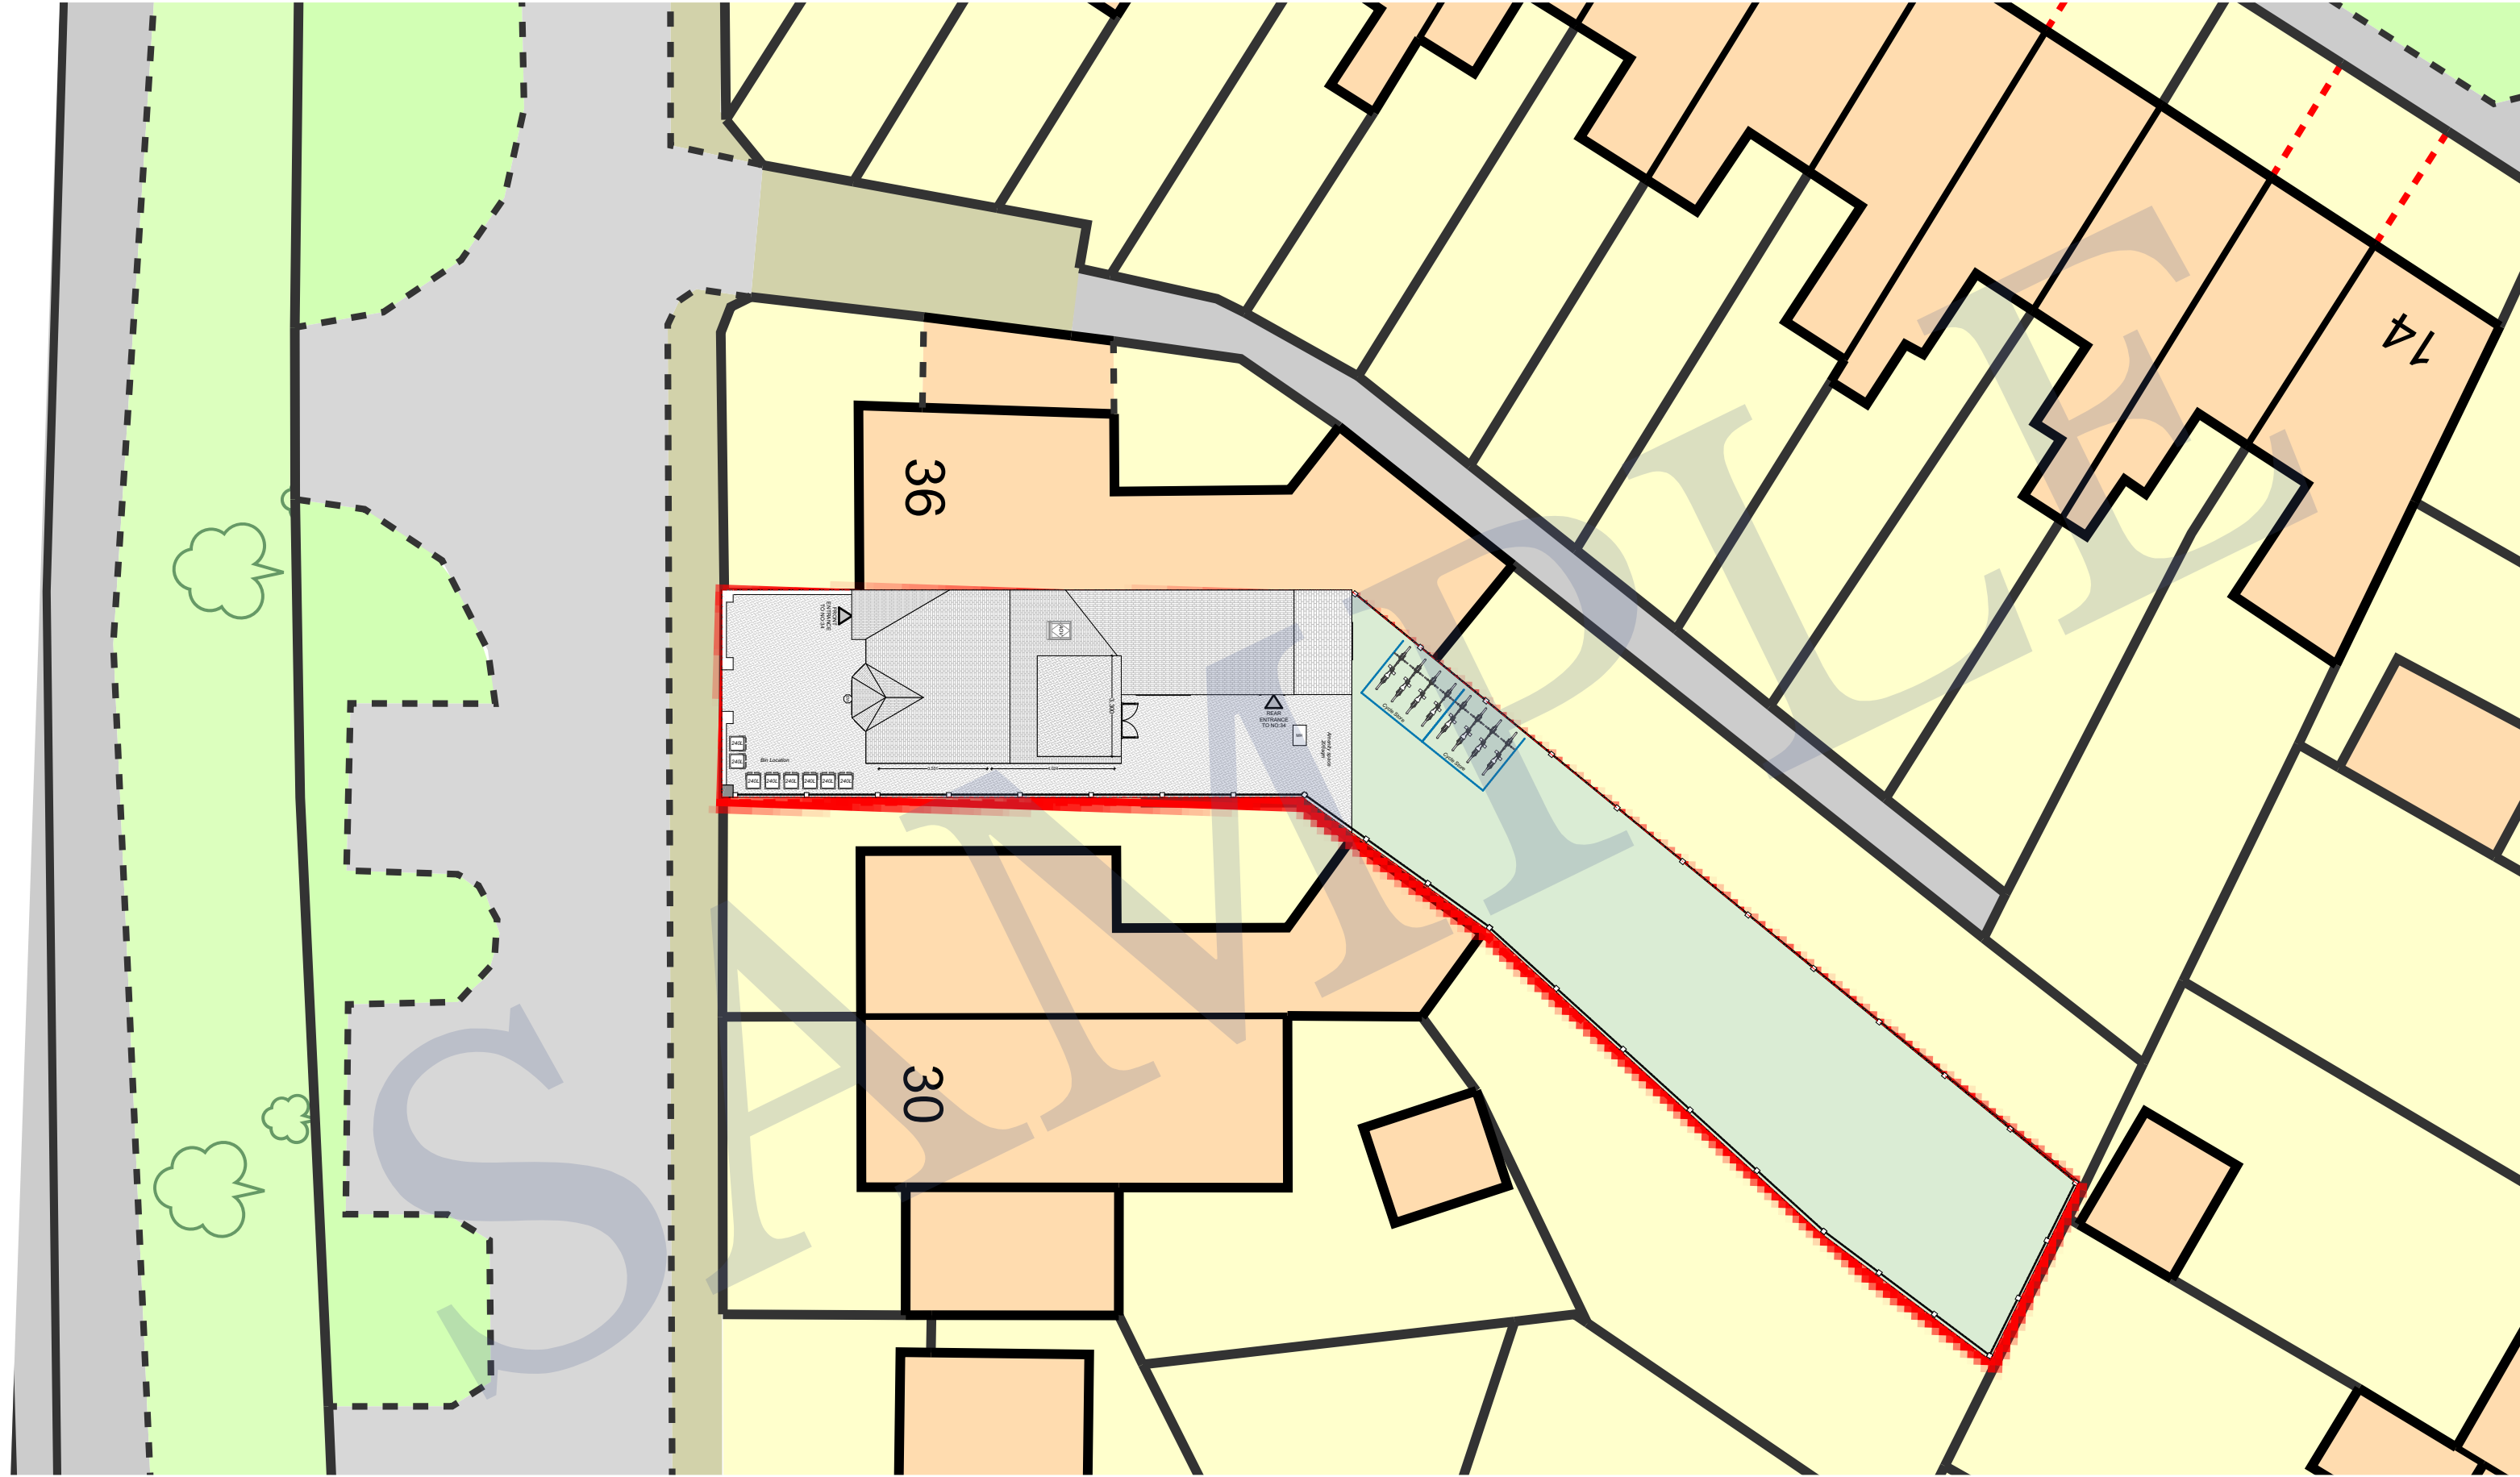


Proposed Site Plan 1:200


 PETER PHILIP DEVELOPMENTS	Status	Scale @ A3	Purpose of Issue	Originator	Project Address	Project Description	Layout Title	Drawing Number								
	PRE LIM	1:100	Planning Permission	Peter Philip Developments		Conversion of Existing Flats (C3) dwelling into Sui Generis 7 Bed HMO with Dormer Extension	Site Plans Proposed Site Plan	project	originator	zone	level	type	role	number	rev	
	Not For Construction	Project No: N/A	Date	Drawn by	Checked by			NG4 2GD	- PPD	- ZZ	- XX	- DR	- N/A	-	1.	01

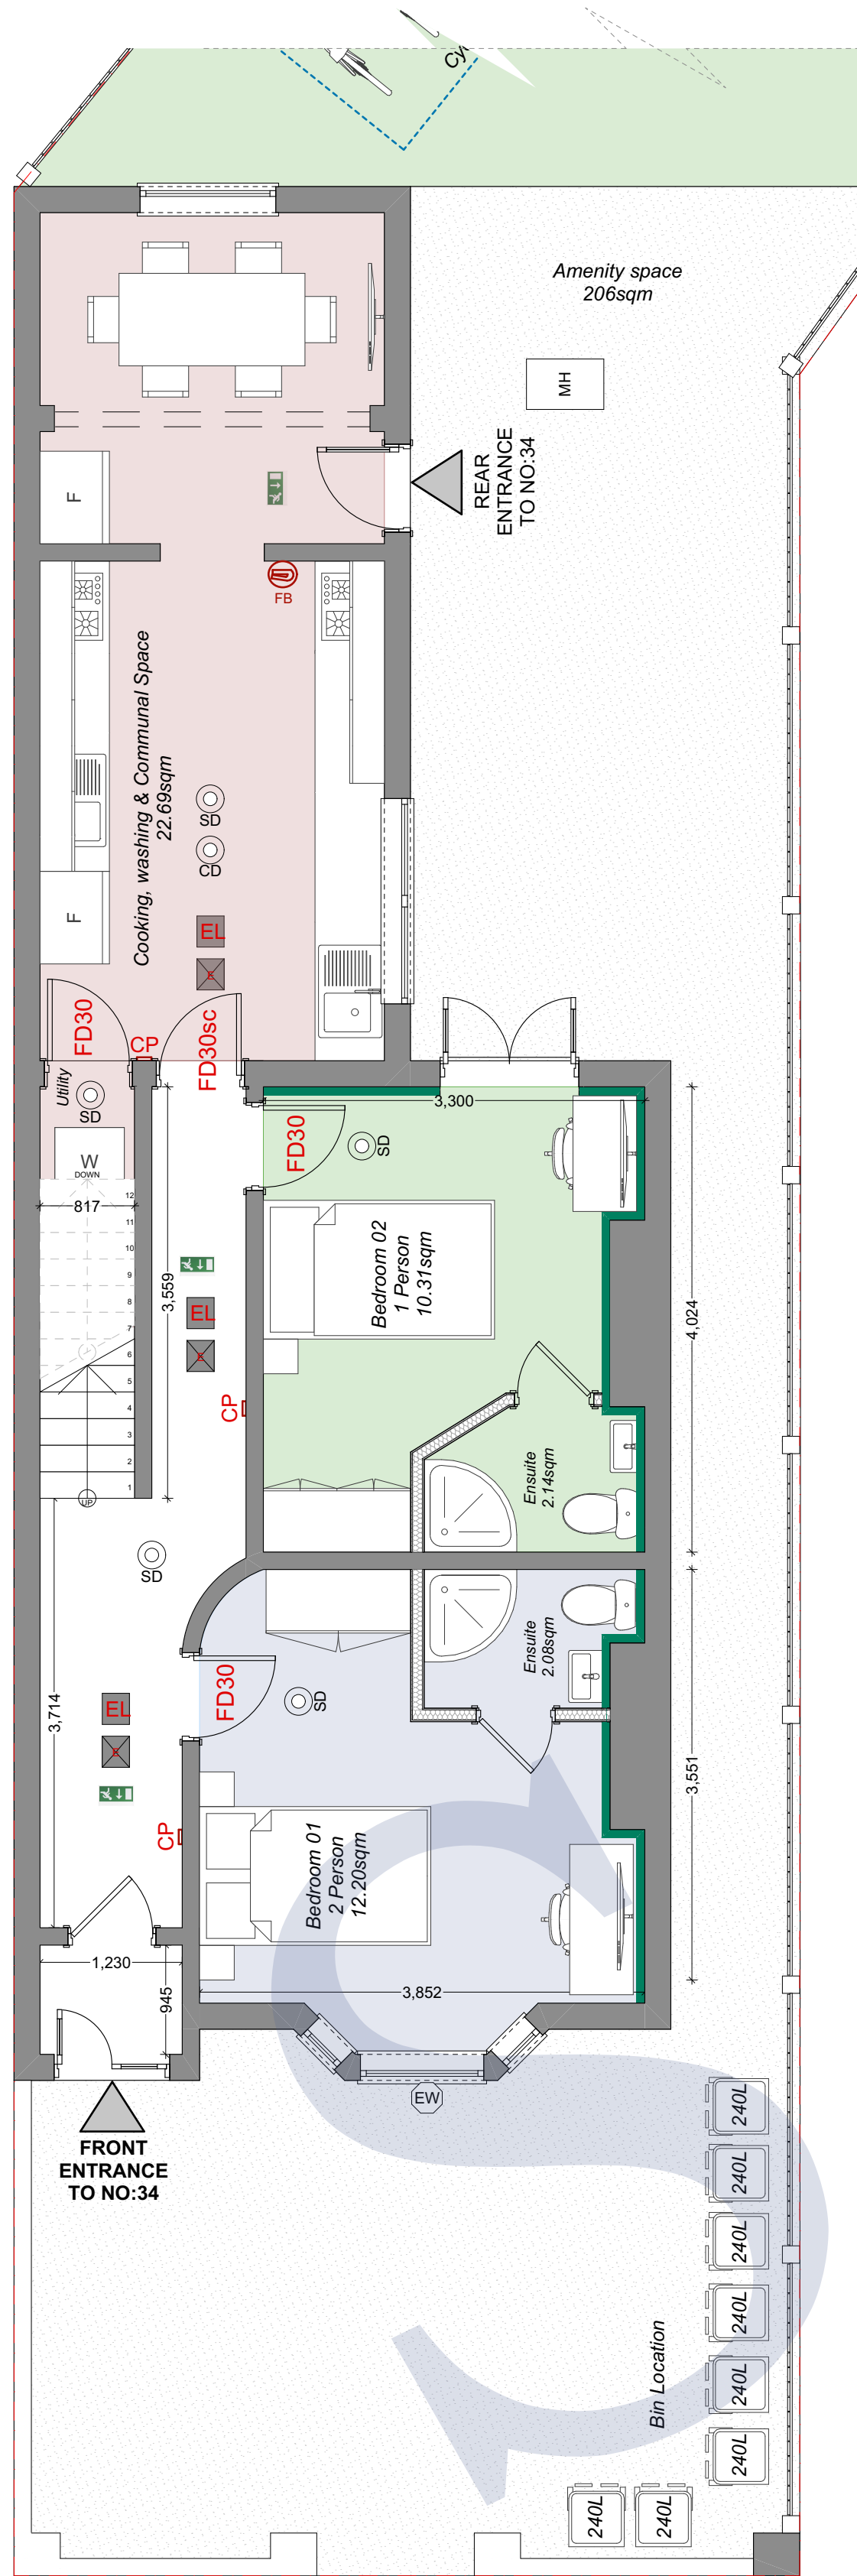


0. Ground Floor
Scale: 1:50

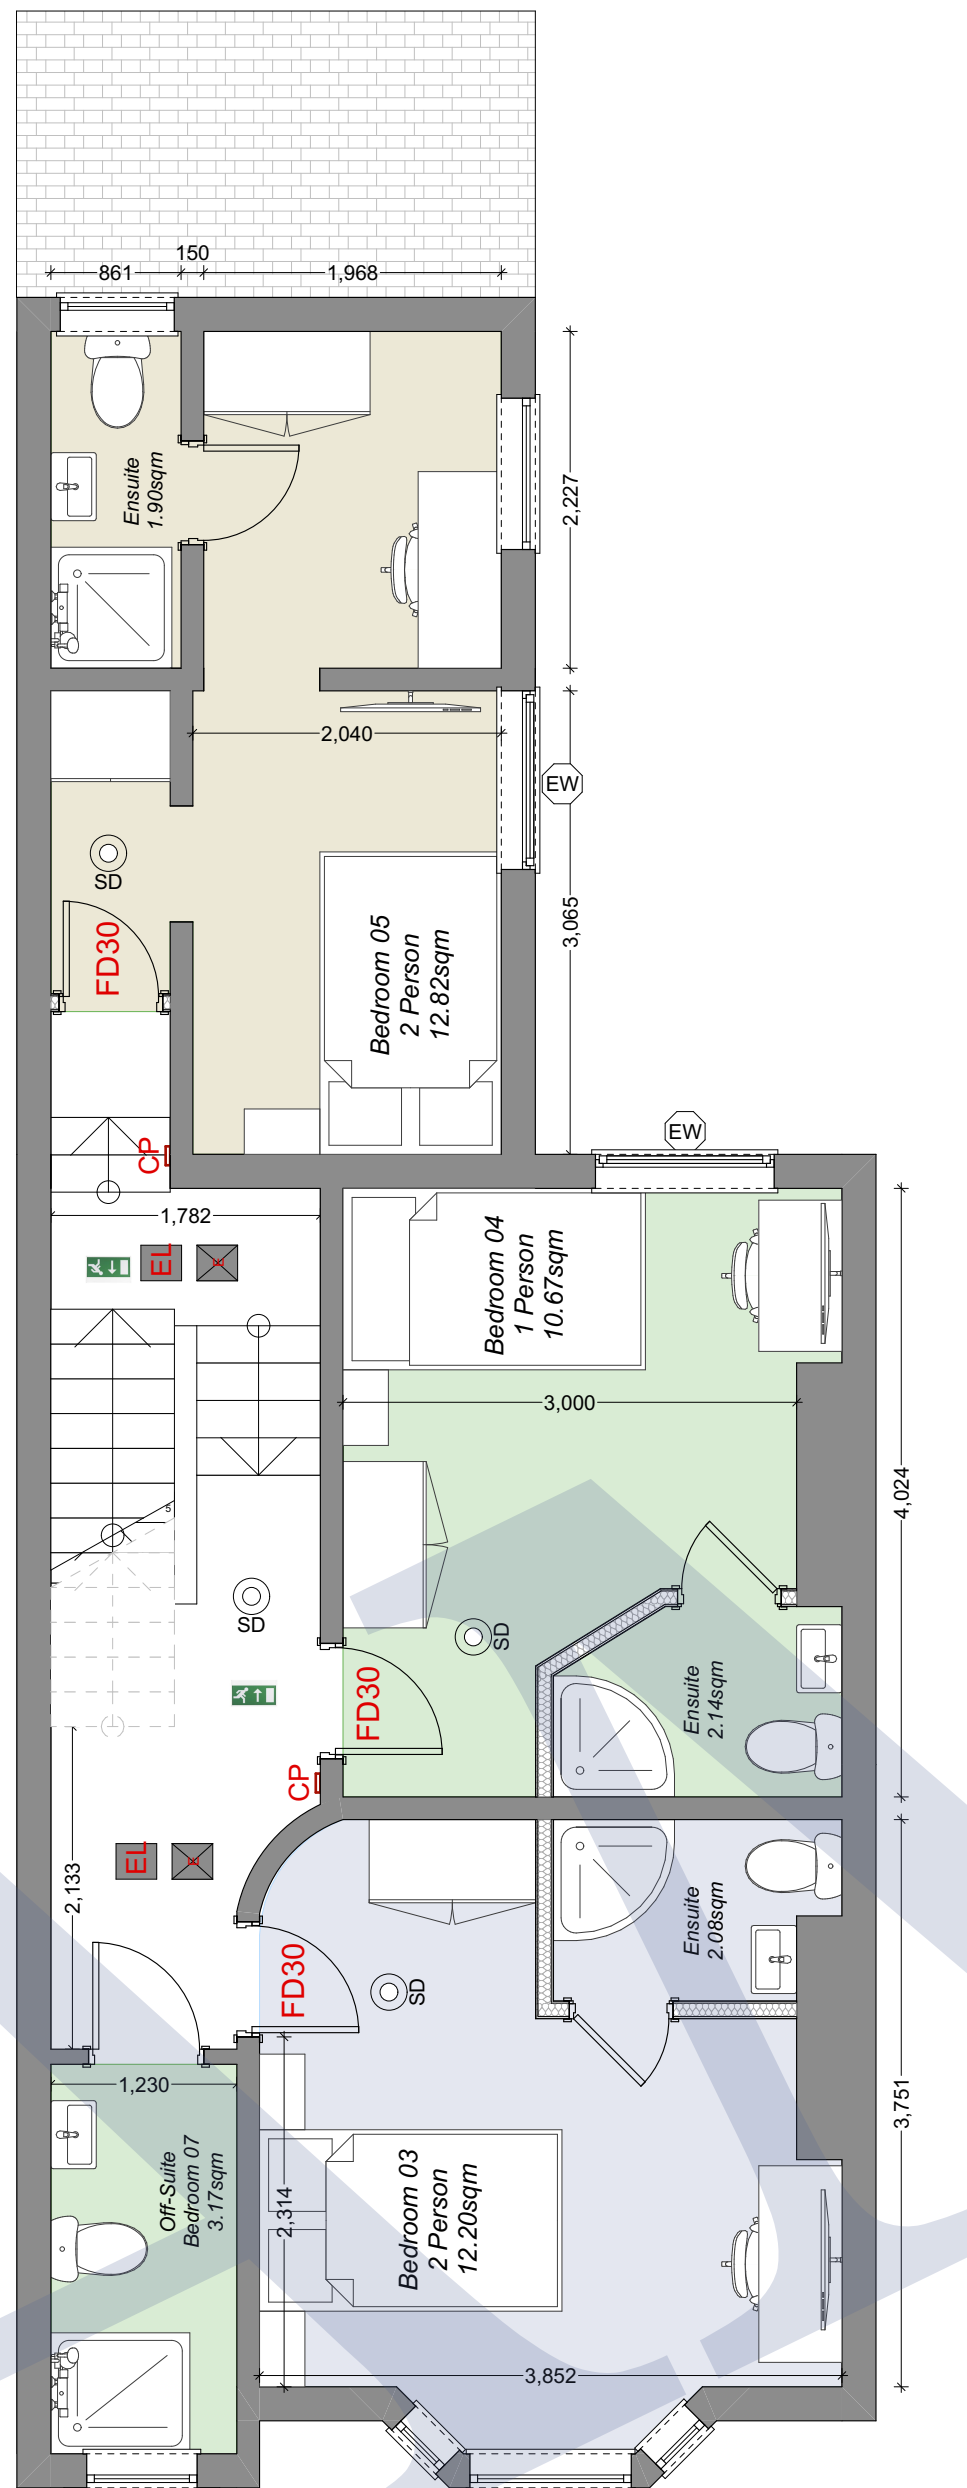

1. First Floor
Scale: 1:50

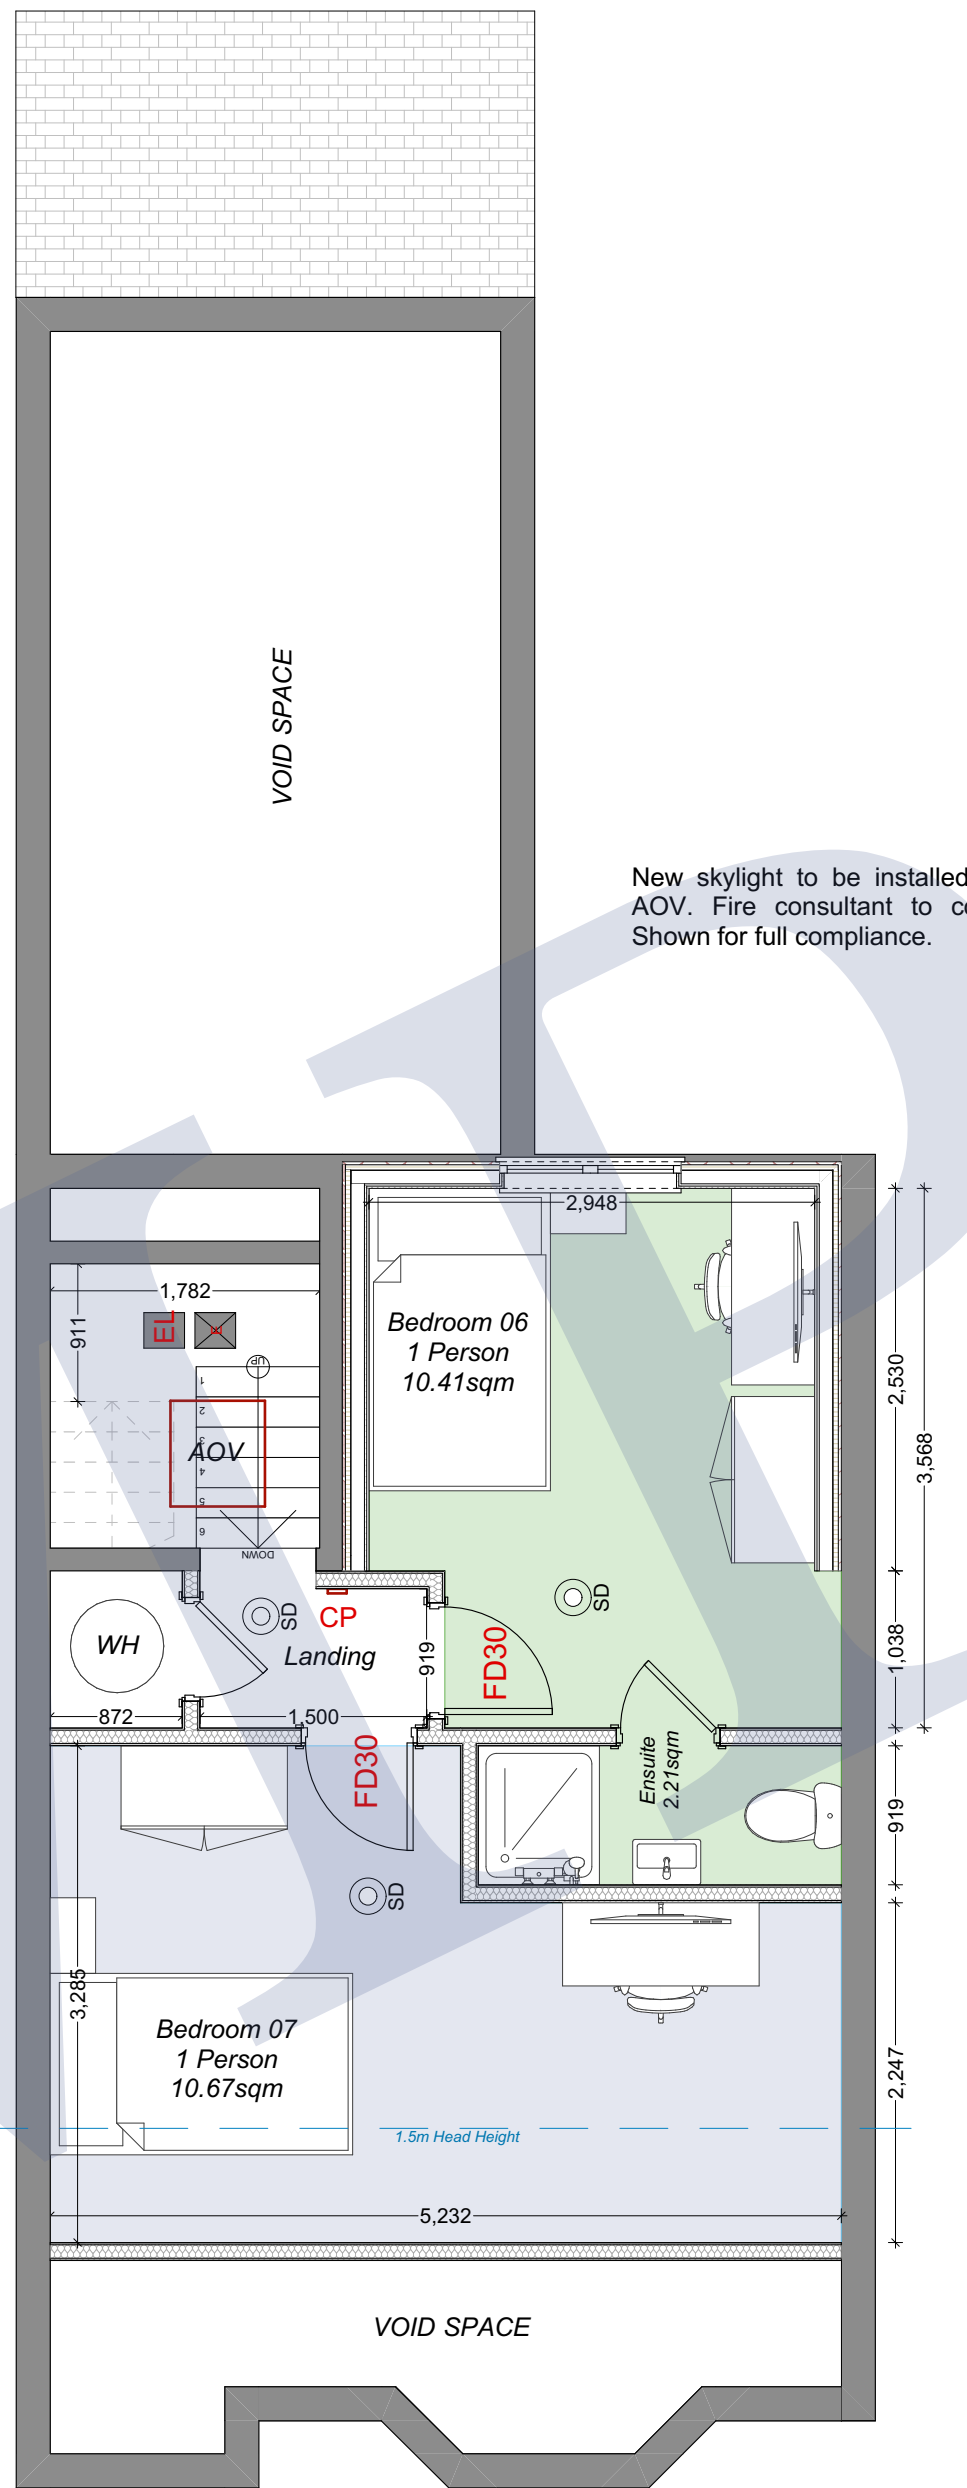

2. Loft Floor
Scale: 1:50

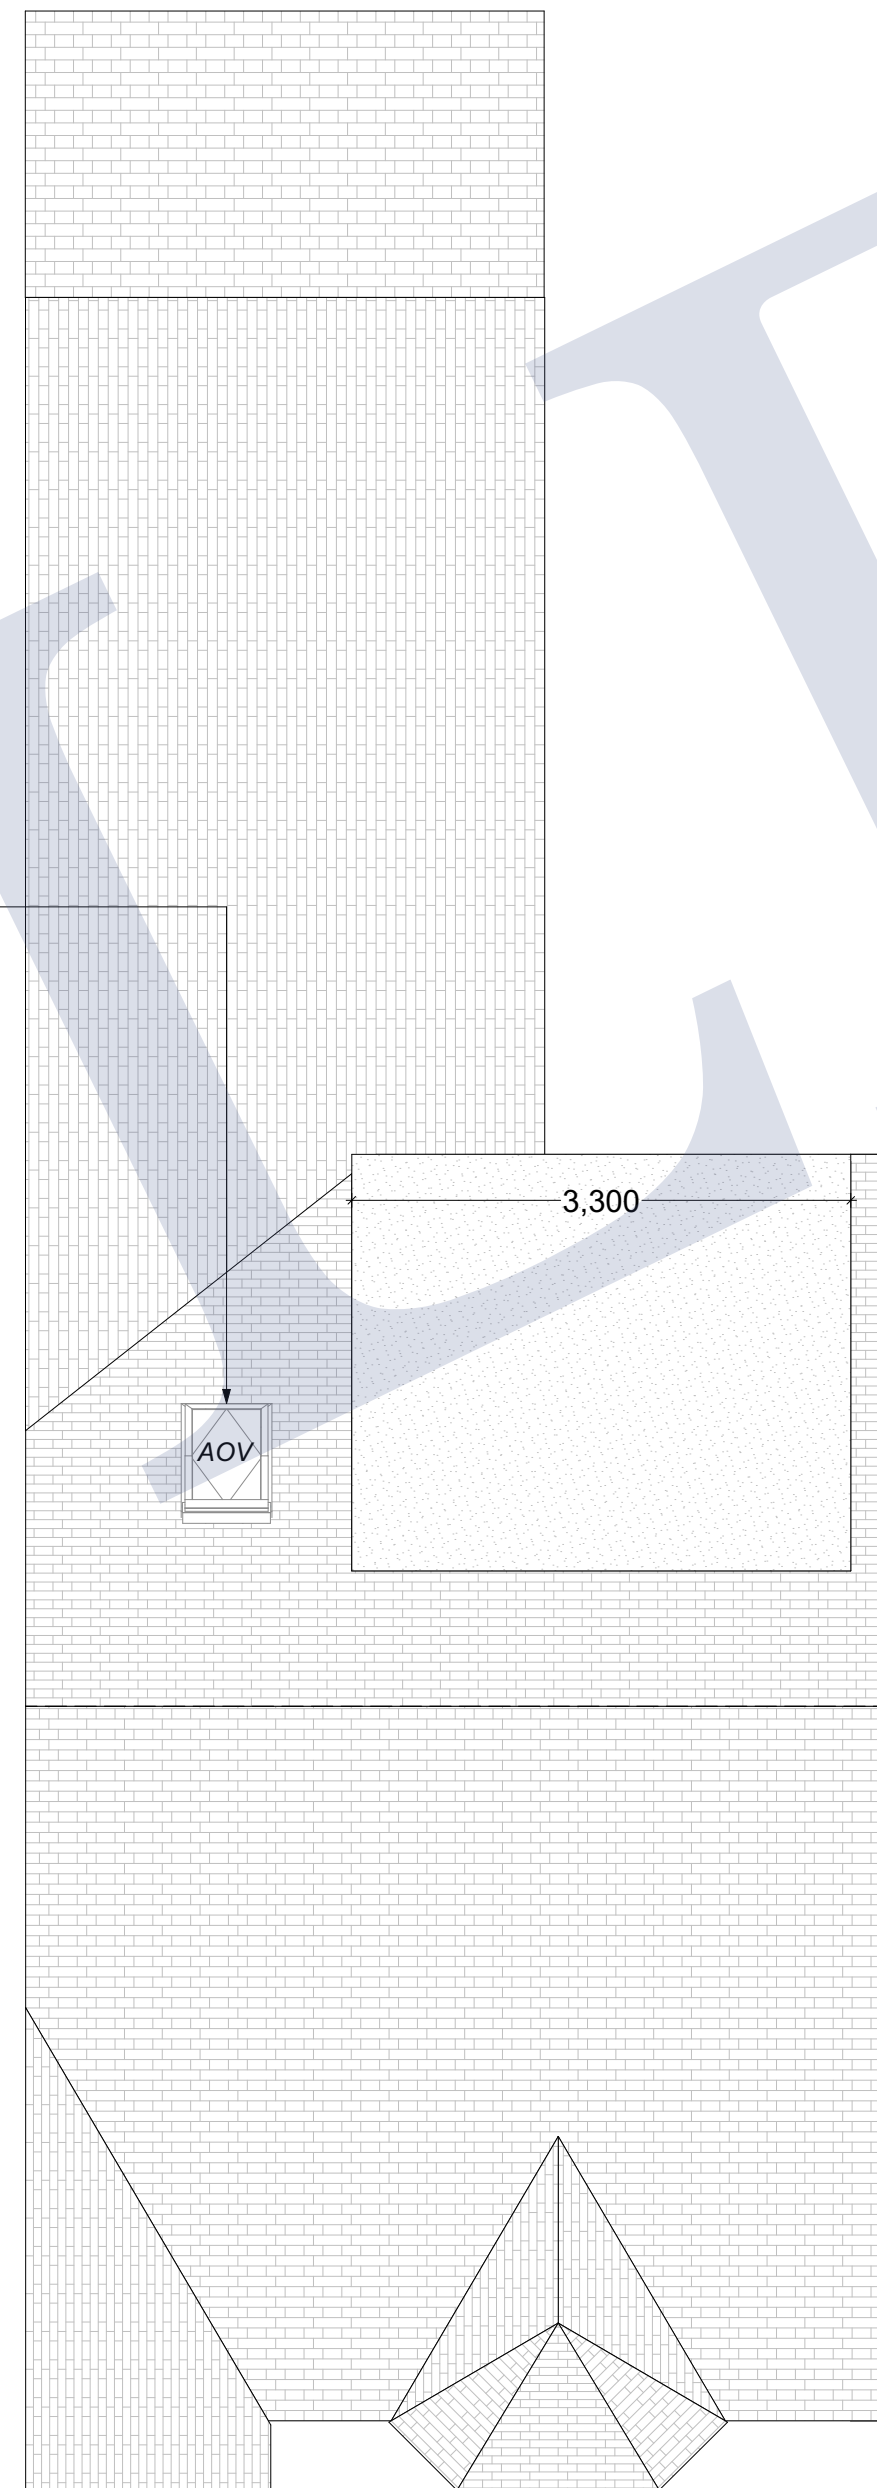

3. Roof Top
Scale: 1:50

TBG WT-04
External Wall Upgrade (0.3 U-Value)


Existing wall face
25x50mm timber batten fixed to existing brickwork vertically
1no layer SuperFOIL SF19+ fixed onto batten via staples at 300mm centres
25x50mm timber batten fixed to/on YBS superquilt horizontally
12.5mm British Gypsum Standard Wallboard fixed to battens
2.5mm Skim

Total Thickness = 72mm
U-Value = 0.3

FIRE SAFETY LEGEND	
FD30	Fire door FD30 (SC Slow Close)
	Grade A Category LD1 fire detection and alarm system as described in BS 5839-6:2013, LD1 or BS 5839-1:2013, L1 with combined heat detection
	Carbon Monoxide Detector (Specification TBC - Combined with SD if required)
	Escape window
	Wall mounted alarm call point to work with Grade A Category LD2 fire alarm system
	Exit sign internally illuminated (BS ISO 3864-1 and BS 5499-4)
	Emergency Light (BS 5266)
	Fire blanket

- Do not scale off this drawing. All dimensions and levels to be checked on site before ordering materials or commencing work.
- The owner of the property (or land) is ultimately responsible for complying with the relevant Planning Rules, Building Regulations and Party Wall etc. Act.
- Any discrepancies to be reported to Peter Philip Developments Ltd prior to construction.
- Peter Philip Developments accepts no liability for any expense, loss or damage arising from any variation made to this drawing or in the execution of the work.



©2023 Peter Philip Developments Limited. All rights reserved.

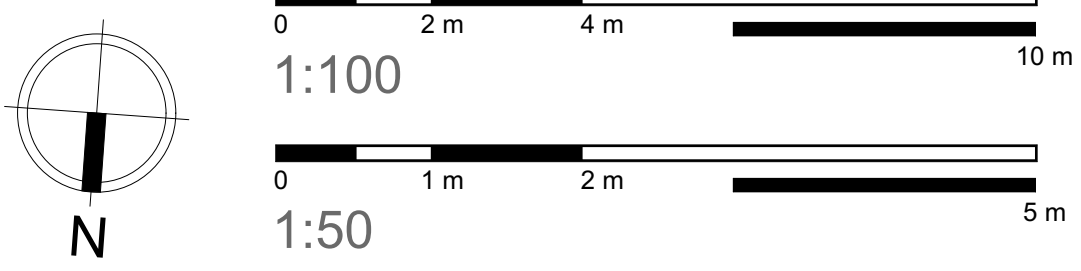


Status	Scale @ A1	Purpose of Issue	Originator	Project Address	Project Description	Layout Title	Drawing Number
PRE LIM	1:50/100	Planning Permission	Peter Philip Developments		Conversion of Existing Flats (C3) dwelling into Sui Generis 7 Bed HMO with Dormer Extension	Proposed A1 Proposed Floor Plans	project originator zone level type role number rev
Not For Construction	Project No: N/A	Date	Drawn by Checked by				NG4 2GD - PPD - - - -N/A- 2



  
1. Do not scale off this drawing. All dimensions and levels to be checked on site before ordering materials or commencing work.
 2. The owner of the property (or land) is ultimately responsible for complying with the relevant Planning Rules, Building Regulations and Party Wall etc. Act.
 3. Any discrepancies to be reported to Peter Philip Developments Ltd prior to construction.
 4. Peter Philip Developments accepts no liability for any expense, loss or damage arising from any variation made to this drawing or in the execution of the work.
- ©2023 Peter Philip Developments Limited. All rights reserved.



	Status	Scale @ A1	Purpose of Issue	Originator	Project Address	Project Description	Layout Title	Drawing Number
	PRE LIM	1:50/100	Planning Permission	Peter Philip Developments		Conversion of Existing Flats (C3) dwelling into Sui Generis 7 Bed HMO with Dormer Extension	Proposed A1 Proposed Elevations	project originator zone level type role number rev
	Not For Construction	Project No: N/A	Date	Drawn by Checked by				NG4 2GD - PPD - - - -N/A - 3

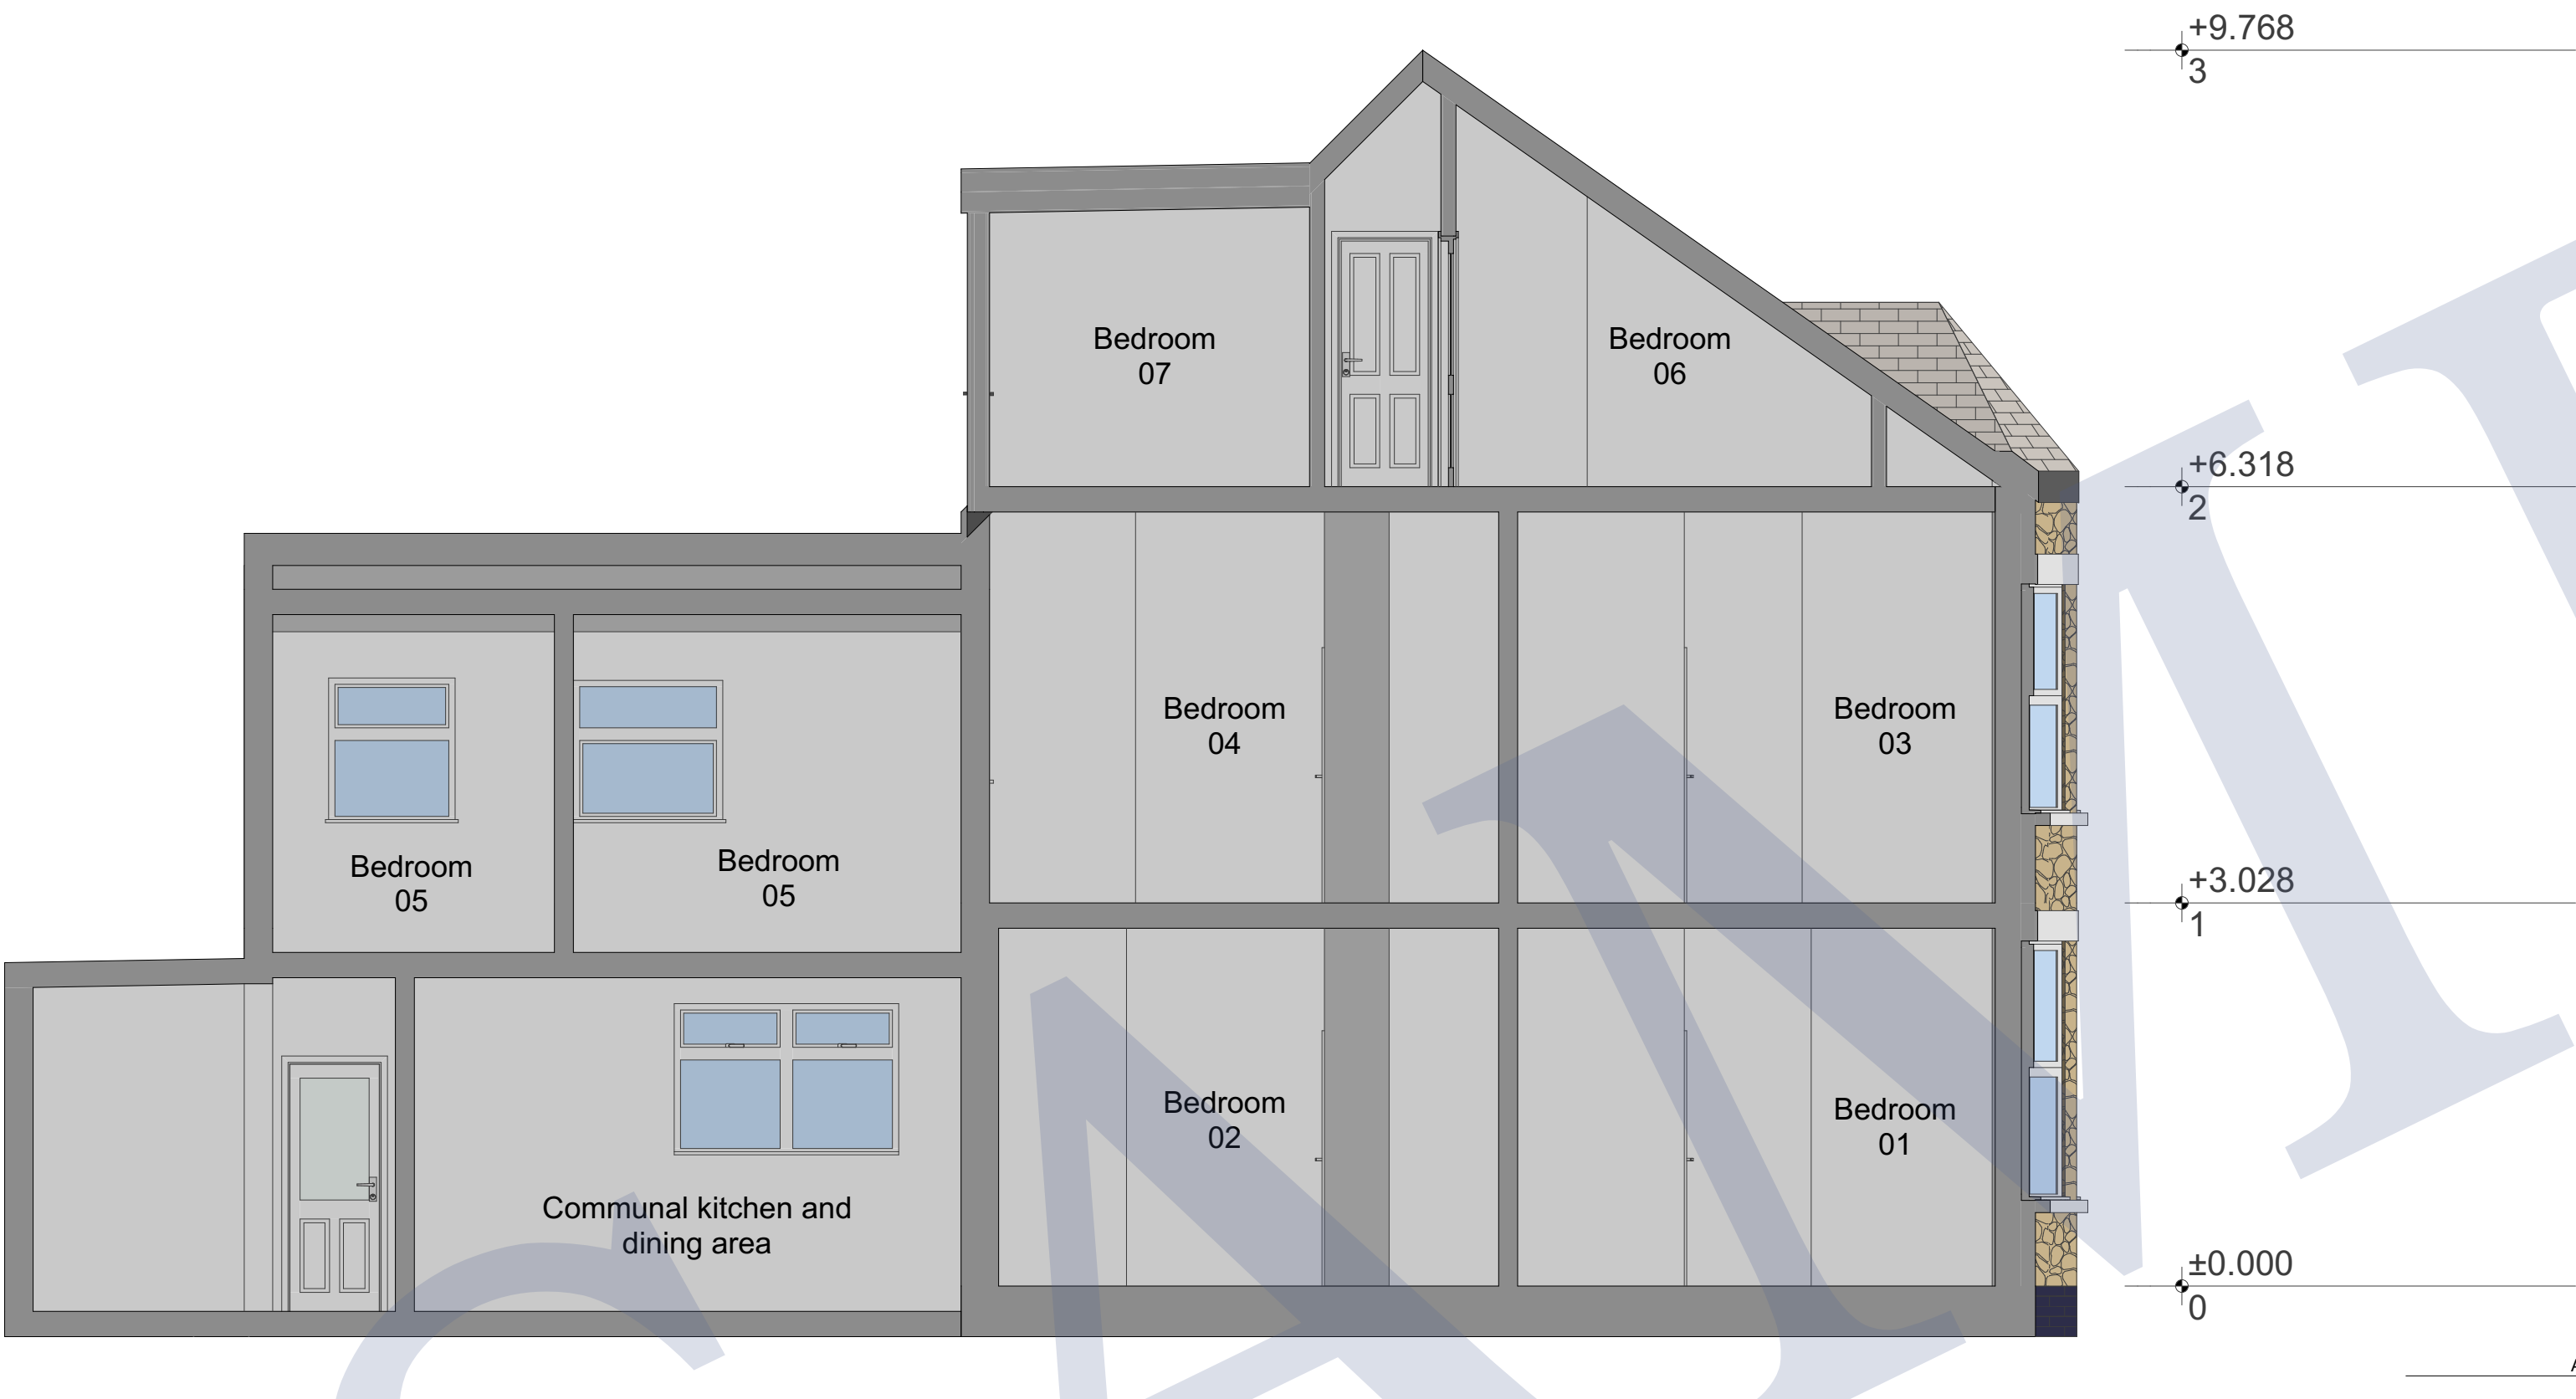


AA Building Section
Scale: 1:50

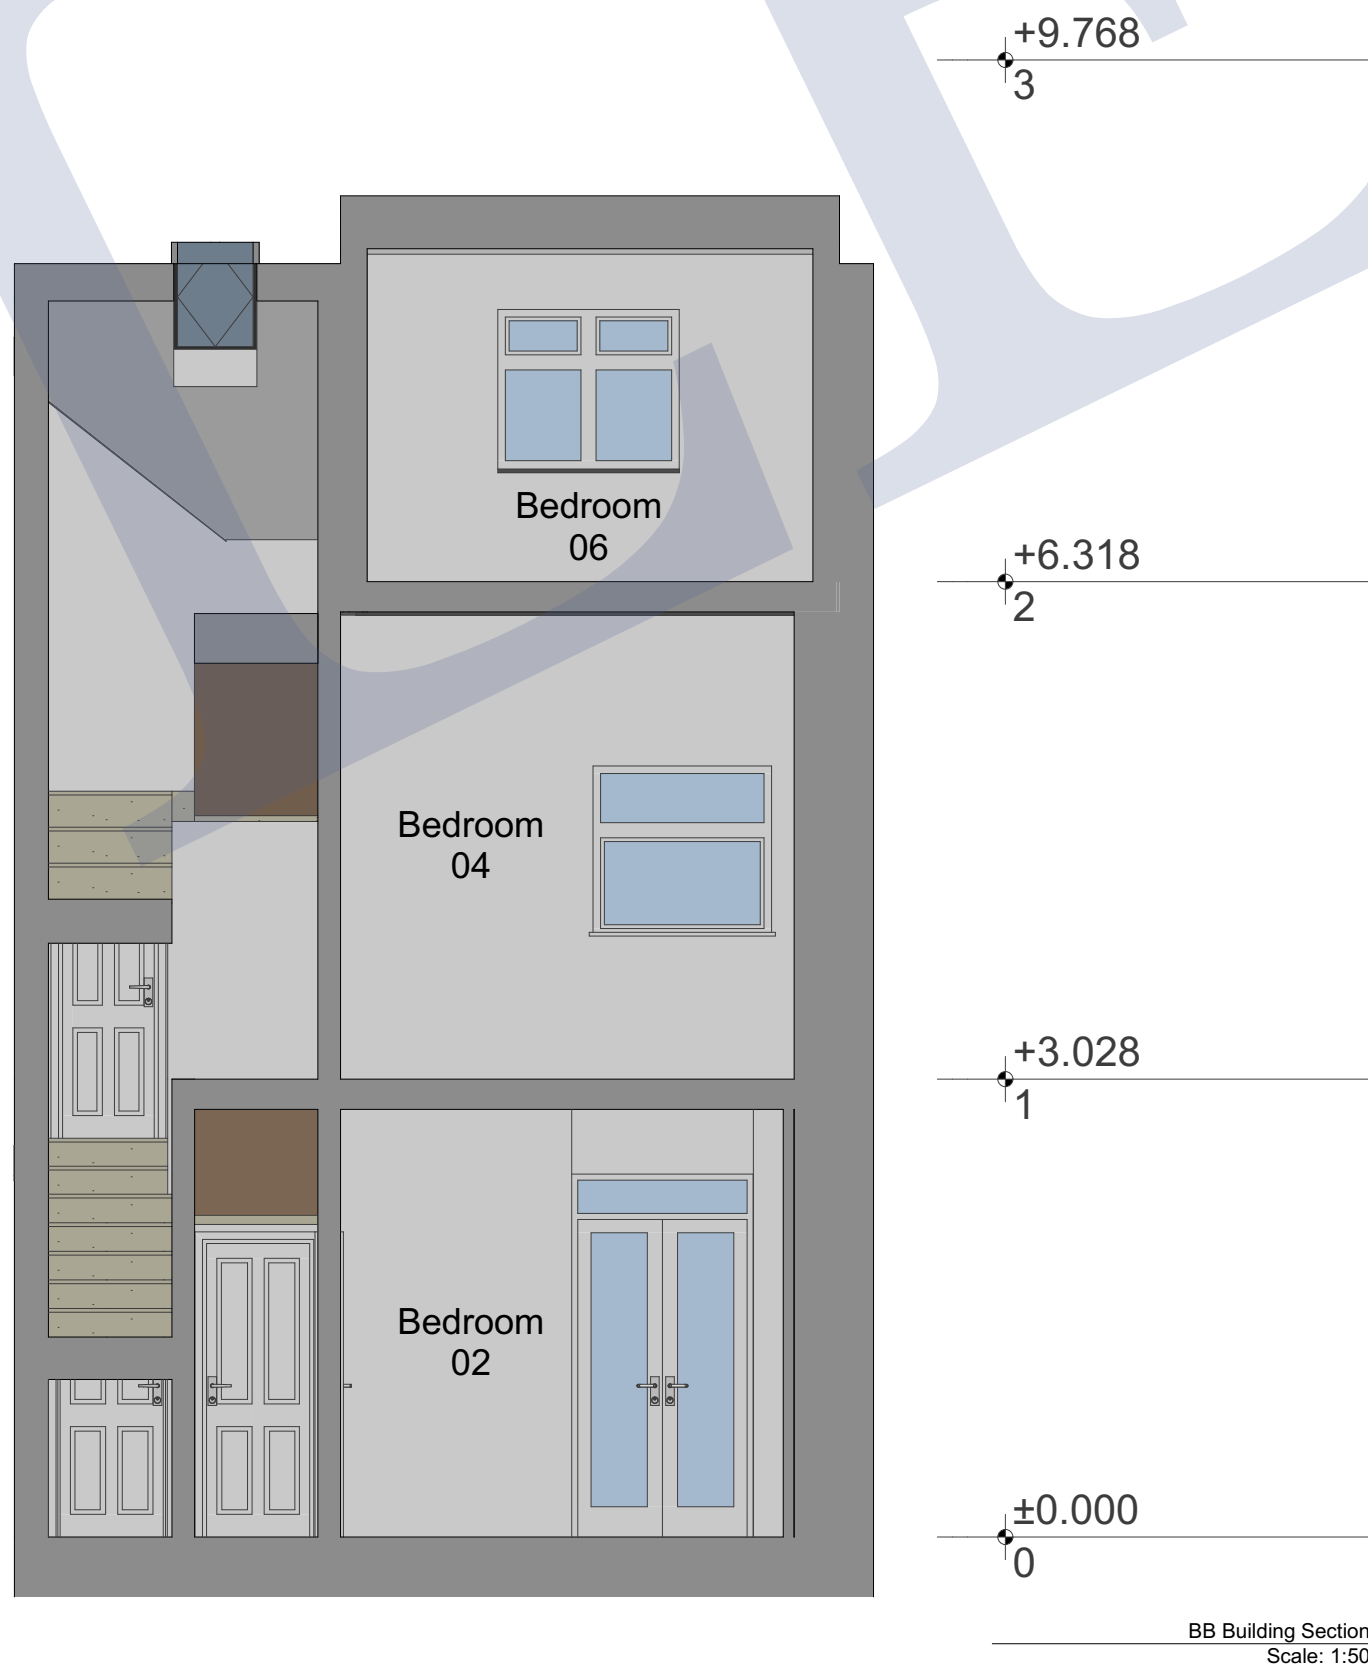

BB Building Section
Scale: 1:50

1. Do not scale off this drawing. All dimensions and levels to be checked on site before ordering materials or commencing work.
2. The owner of the property (or land) is ultimately responsible for complying with the relevant Planning Rules, Building Regulations and Party Wall etc. Act.
3. Any discrepancies to be reported to Peter Philip Developments Ltd prior to construction.
4. Peter Philip Developments accepts no liability for any expense, loss or damage arising from any variation made to this drawing or in the execution of the work.

©2023 Peter Philip Developments Limited. All rights reserved.

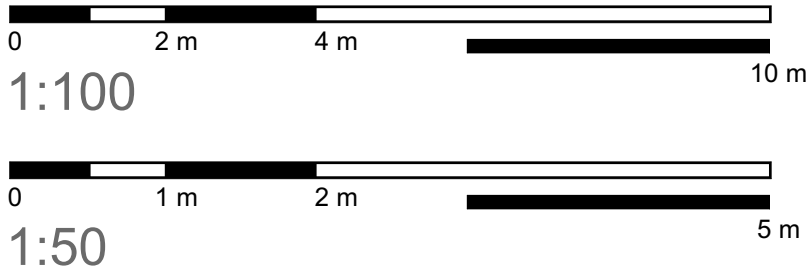

	Status	Scale @ A1	Purpose of Issue	Originator	Project Address	Project Description	Layout Title	Drawing Number
	PRE LIM	1:50/100	Planning Permission	Peter Philip Developments		Conversion of Existing Flats (C3) dwelling into Sui Generis 7 Bed HMO with Dormer Extension	Proposed A1 Proposed Sections	project originator zone level type role number rev
	Not For Construction	Project No: N/A	Date	Drawn by Checked by				NG4 2GD - PPD - - - -N/A - 4